


- NOTES:
1. SEWER LINES DIGITIZED FROM UTILITY PLANS BY MOSER MAYER PHOENIX DATED NOVEMBER 1997.
 2. PLANS SHOWN ARE NOT AS-BUILTS.

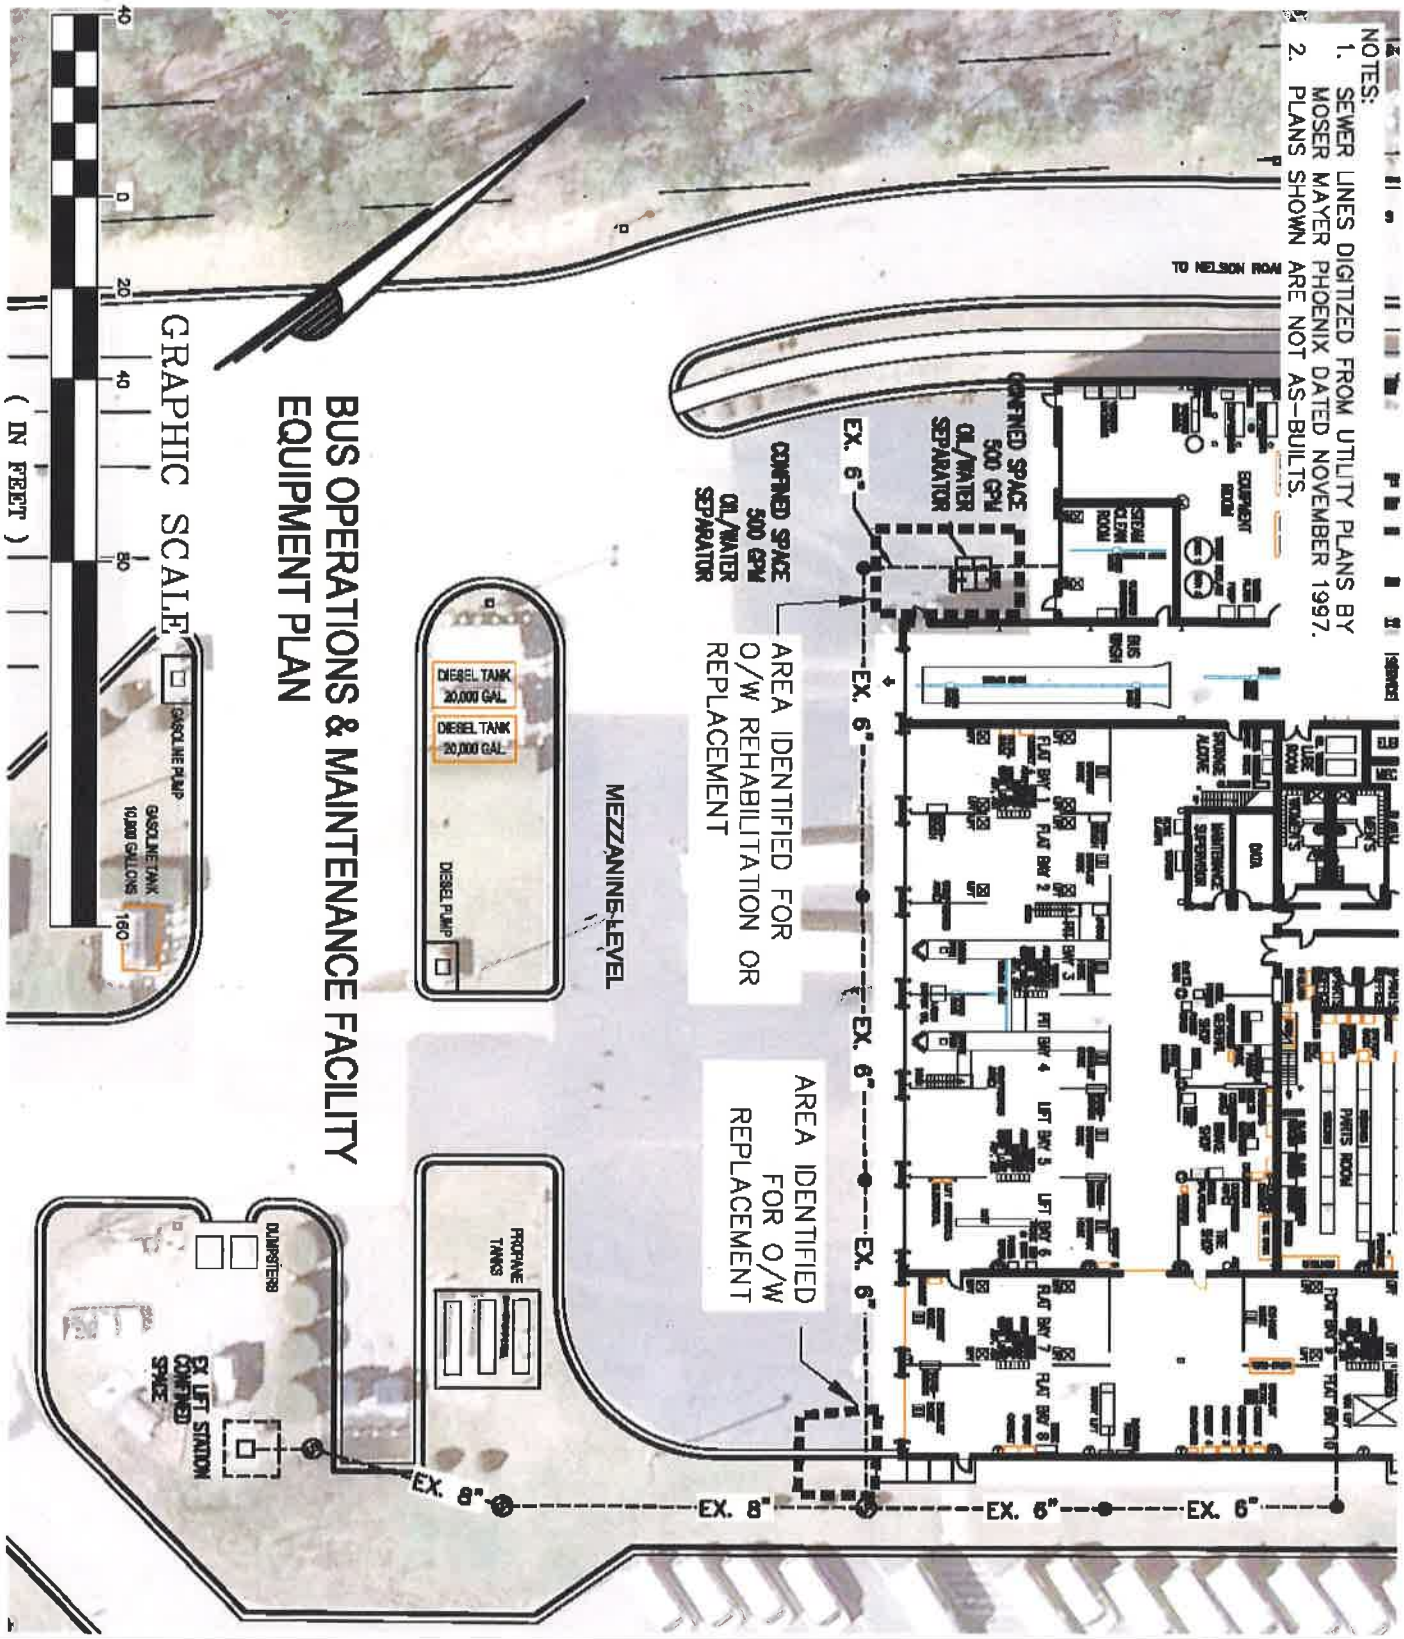

BUS OPERATIONS & MAINTENANCE FACILITY EQUIPMENT PLAN

GRAPHIC SCALE



1 inch = 40 ft

Date 11/30/17	DRAWN BY: EMS
Scale As Noted	CHECKED BY: JS
Capital Development Office: 4600 Emperor Blvd Suite 100 Durham, NC 27713	PO Box 13787 RTP, NC 27709 GOTRIANGLE.ORG (919) 483-7510 Fax: (919) 485-7541

**BUS OPERATIONS MAINTENANCE FACILITY
OIL WATER SEPARATOR
EXHIBIT
TTA-17-009
5201 NELSON ROAD, MORRISVILLE, NC 27560**

